



# City of Chicago



Or2020-152

Office of the City Clerk

## Document Tracking Sheet

|                                 |  |
|---------------------------------|--|
| <b>Meeting Date:</b>            | 5/19/2020  |
| <b>Sponsor(s):</b>              | Hopkins (2)  |
| <b>Type:</b>                    | Order  |
| <b>Title:</b>                   | Issuance of permits for sign(s)/signboard(s) at 225 E<br>Chicago Ave - north elevation |
| <b>Committee(s) Assignment:</b> | Committee on Zoning, Landmarks and Building Standards                                  |

CITY COUNCIL  
COMMITTEE ON ZONING, LANDMARKS AND BUILDING STANDARDS

COUNCIL ORDER

RE: Approval of sign over 100 square feet in area or over 24 feet above grade

ORDERED, that the City Council hereby approves the following sign application submitted by:

Applicant\*: Ann & Robert H. Lurie Children's Hospital of Chicago

(\* The Applicant is the owner of the real property or the business tenant of the real property. Do not list the sign contractor, sign erector, sign company or advertising entity in the above space.)

This Order approves the following sign in accordance with Municipal Code of Chicago Section 13-20-680:

Address of Sign: 225 E Chicago Ave Chicago, IL 60611

Zoning District: DX-12

DOB Sign Permit Application #: 100869517

Sign Details:

1. On-premise  OR Off-premise

2. Static sign  OR Dynamic-image display sign

3. Number of sign faces 1

4. Projecting over the public way No (Yes or No) If yes, Public Way Use #: \_\_\_\_\_

5. Dimensions: Length 34 feet 3 inches Height 5 feet 4 inches

Total square feet in area: 183

6. Height above grade: 24 feet 4 inches *To top of sign or sign structure*


7. Elevation (side of building or lot where the sign will be erected): North Elevation (E Chicago Ave)

8. Name of Sign Contractor/Erector: South Water Signs

To be legal, such sign shall comply with all provisions of Title 17 of the Chicago Municipal Code ("Zoning Ordinance") and all other provisions of the Municipal Code governing the permitting, construction and maintenance and removal of signs and sign structures. Failure of the applicant and the applicant's successors to comply shall be grounds for invalidation or revocation of the sign permit.

Brian Hopkins  
Alderman

02  
Ward

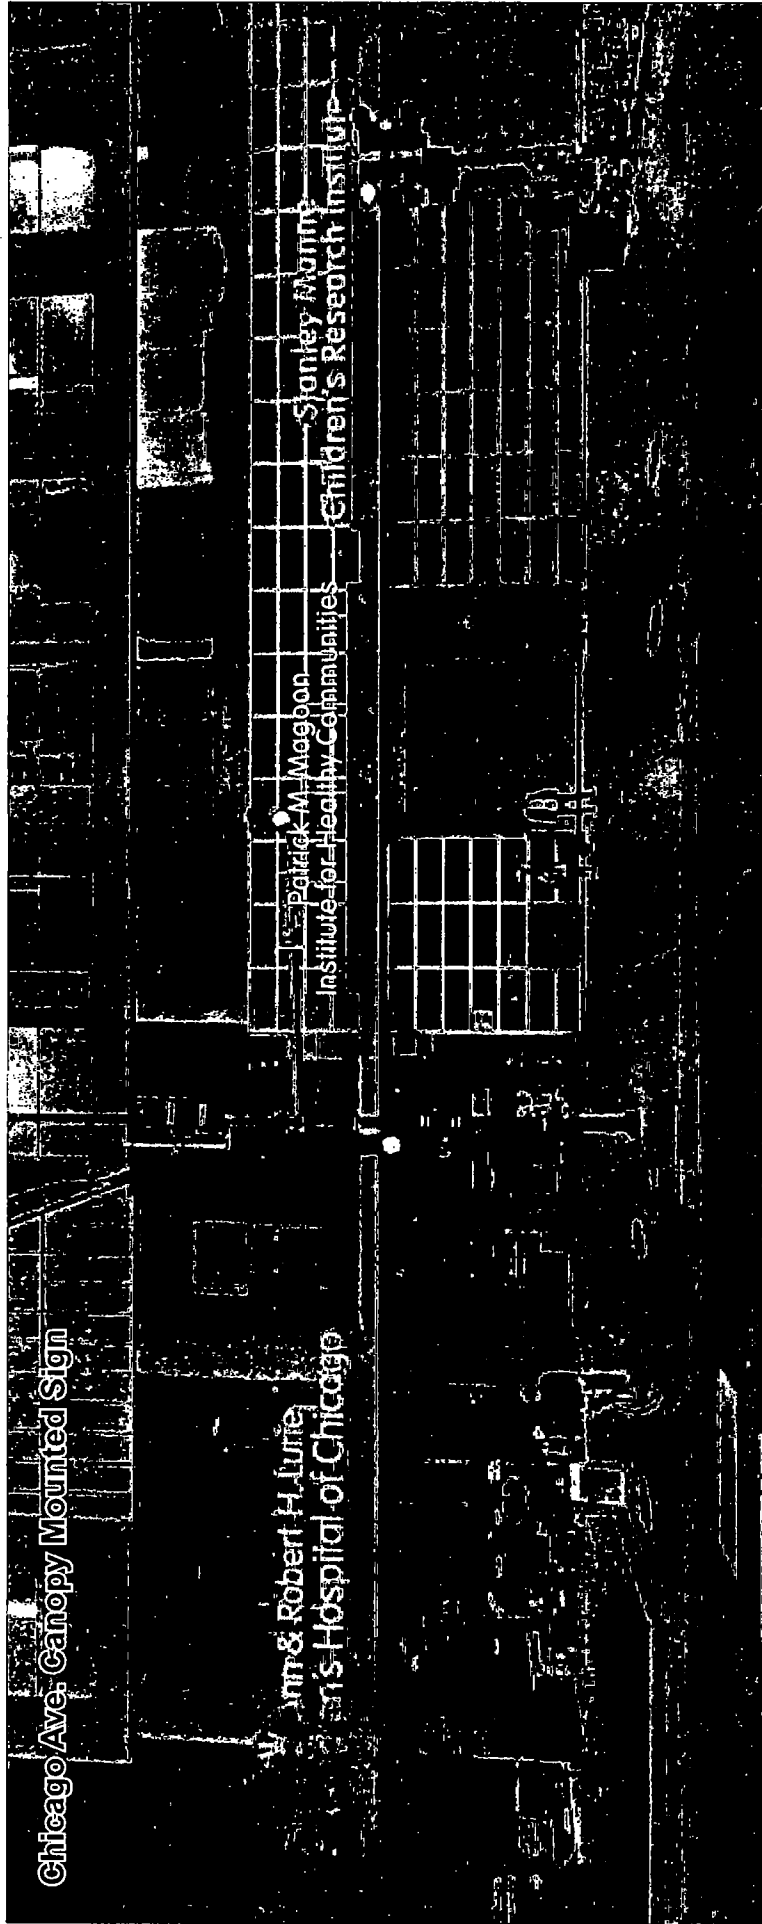

Approximate renderings not to scale.



South Water Signs

Client:  
Ann & Robert Lurie Children's Hospital  
Patrick Magboon Institute for Healthy Communities

Custom v. Approval

Project Name & Location  
Chicago Ave  
Chicago, IL

Job Number  
7037945

Date  
11.13.19

Drawn By  
SW


SWS W/O CODE  
 F  E  R  O  
 V  C  P

Revisions:  
 1: 11/19 SW  
 2: 11/20 SW  
 3: 11/20 SW

THIS DRAWING IS PROPERTY  
OF SOUTH WATER SIGNS  
ALL RIGHTS OF REPRODUCTION  
ARE RESERVED BY  
SOUTH WATER SIGNS



**TRIMCAP-LESS FACE-LIT CHANNEL LETTERS  
LED ILLUMINATION - RACEWAY MOUNT**

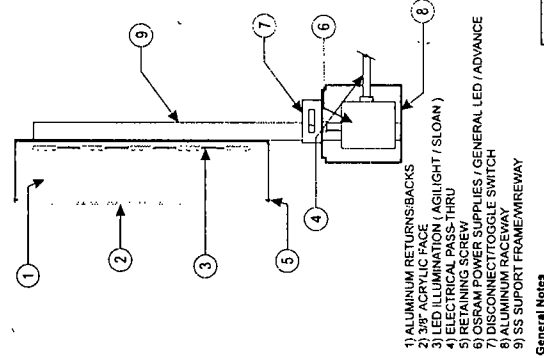

- 1) ALUMINUM RETURNS/BACKS
- 2) 3/4" ACRYLIC FACE
- 3) LED ILLUMINATION (AGILIGHT / SLOAN)
- 4) ELECTRICAL PASS-THRU
- 5) RETAINING SCREW
- 6) OSRAM POWER SUPPLIES / GENERAL LED / ADVANCE
- 7) DISCONNECT TOGGLE SWITCH
- 8) ALUMINUM RETURNS
- 9) SS SUPPORT FRAME/RACEWAY

**General Notes:**  
 1) Caps 2 Self Adjusting Power Supply  
 60W 12V 5Amp Per Foot  
 All wiring bonded and grounded

**MOUNTING HARDWARE**


**Lag Screw**  
 Wood & Masonry Applications

**Toggle Bolt**  
 Hollow Walls

**Wedge Anchor**  
 Masonry Applications

**Sleeve Anchor**  
 Masonry Applications

**Thru-Bolt w/ U-Channel**  
 Hollow Walls w/ Rear-Faces

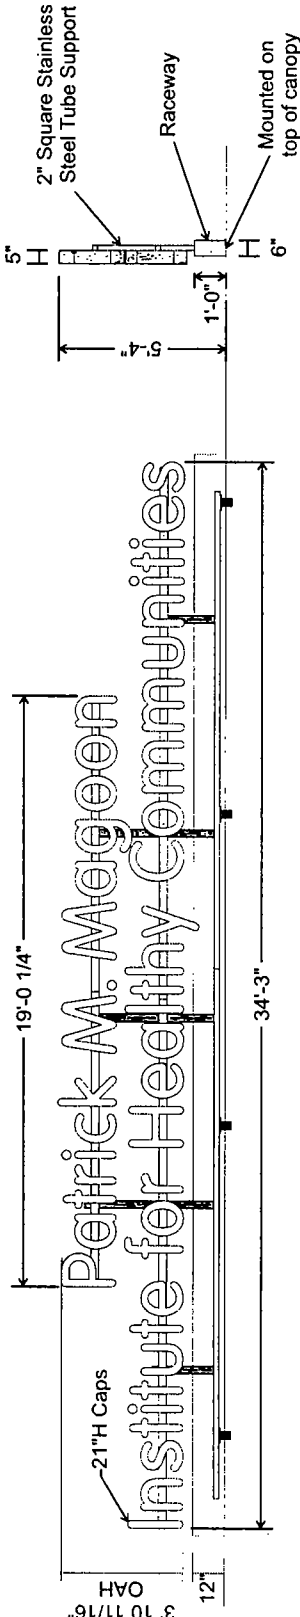

**133.29 Sq. Ft.**

**Scale: 1/4" = 1'-0"**

Fabricated 8" Deep Stainless Steel letters internally illuminated with white LED lighting #4 Horizontal Brushed returns - \*See LED notes for matching existing conditions

1/2" Clear polycarbonate reverse-push (Trimless) through routed faces with second surface white Diffuser (3M 3635-70) & First surface White Vinyl (3M 230-20) for even lighting

Letters mounted to common 3" x 3" common aluminum support rails with additional vertical 1" x 1" square tube supports - Painted to match Building (P10 Medium Gray)

\*Paint match sample required for Medium Gray - \*See following layouts for vertical 1" x 1" supports

Fabricated 12"H x 32"W aluminum clam-shell shroud to hide all mounting, installed after sign and anchored directly with tek screws into canopy. Painted to match building (P10 Medium Gray)

Supports & rail sections mounted to existing steel canopy with sandwiched steel plates  
 \*Additional canopy information/survey req.\*

Qty 2 Sets of letters  
 \*All materials and finishes to match existing letters

**Superior & Chicago Ave - Canopy Mounted ID Signs**

**Proposed LED Lighting**

Sylvania BackLED MB  
 120° Angle, 6500K White, 2 mods / foot  
 OT60W/12V/UNV (120-277) LED Drivers  
 DCA-10-120 Dimming Controller, WCL-10 Lutron Nova T Dimmer  
 wall control provided to manually match brightness of existing letterset  
 \*LED layout req. for exact driver count and breakdown\*

**Client:**  
 Ann & Robert Lurie Children's Hospital  
 Patrick Maggion Inst. for Healthy Communities

**Customer Approval:**

**Project Name & Location:**  
 Chicago Ave  
 Chicago, IL

**Job Number:**  
 7037945

**Date:**  
 11.13.19

**Drawn By:**  
 SW

**3WS W/O CORE:**  
 F  E  R  O  P  
 V  C  P

**Revision:**  
 11.19.19 SW  
 11.26.19 SW  
 03.17.20 SW  
 03.06.20 SW

**South Water Signs**